


WESTERN RESERVE BUILDING
CLEVELAND, OHIO 44113, 216.781.9144

KEEVA J. KEKST ASSOCIATES ARCHITECTS INC.

RICHMOND ROAD CONDOMINIUMS
RICHMOND ROAD BEACHWOOD, OHIO
CONDOMINIUM CONCEPTS INC.
CLEVELAND

CONSTRUCTION DRAWINGS

Date: 5-29-84

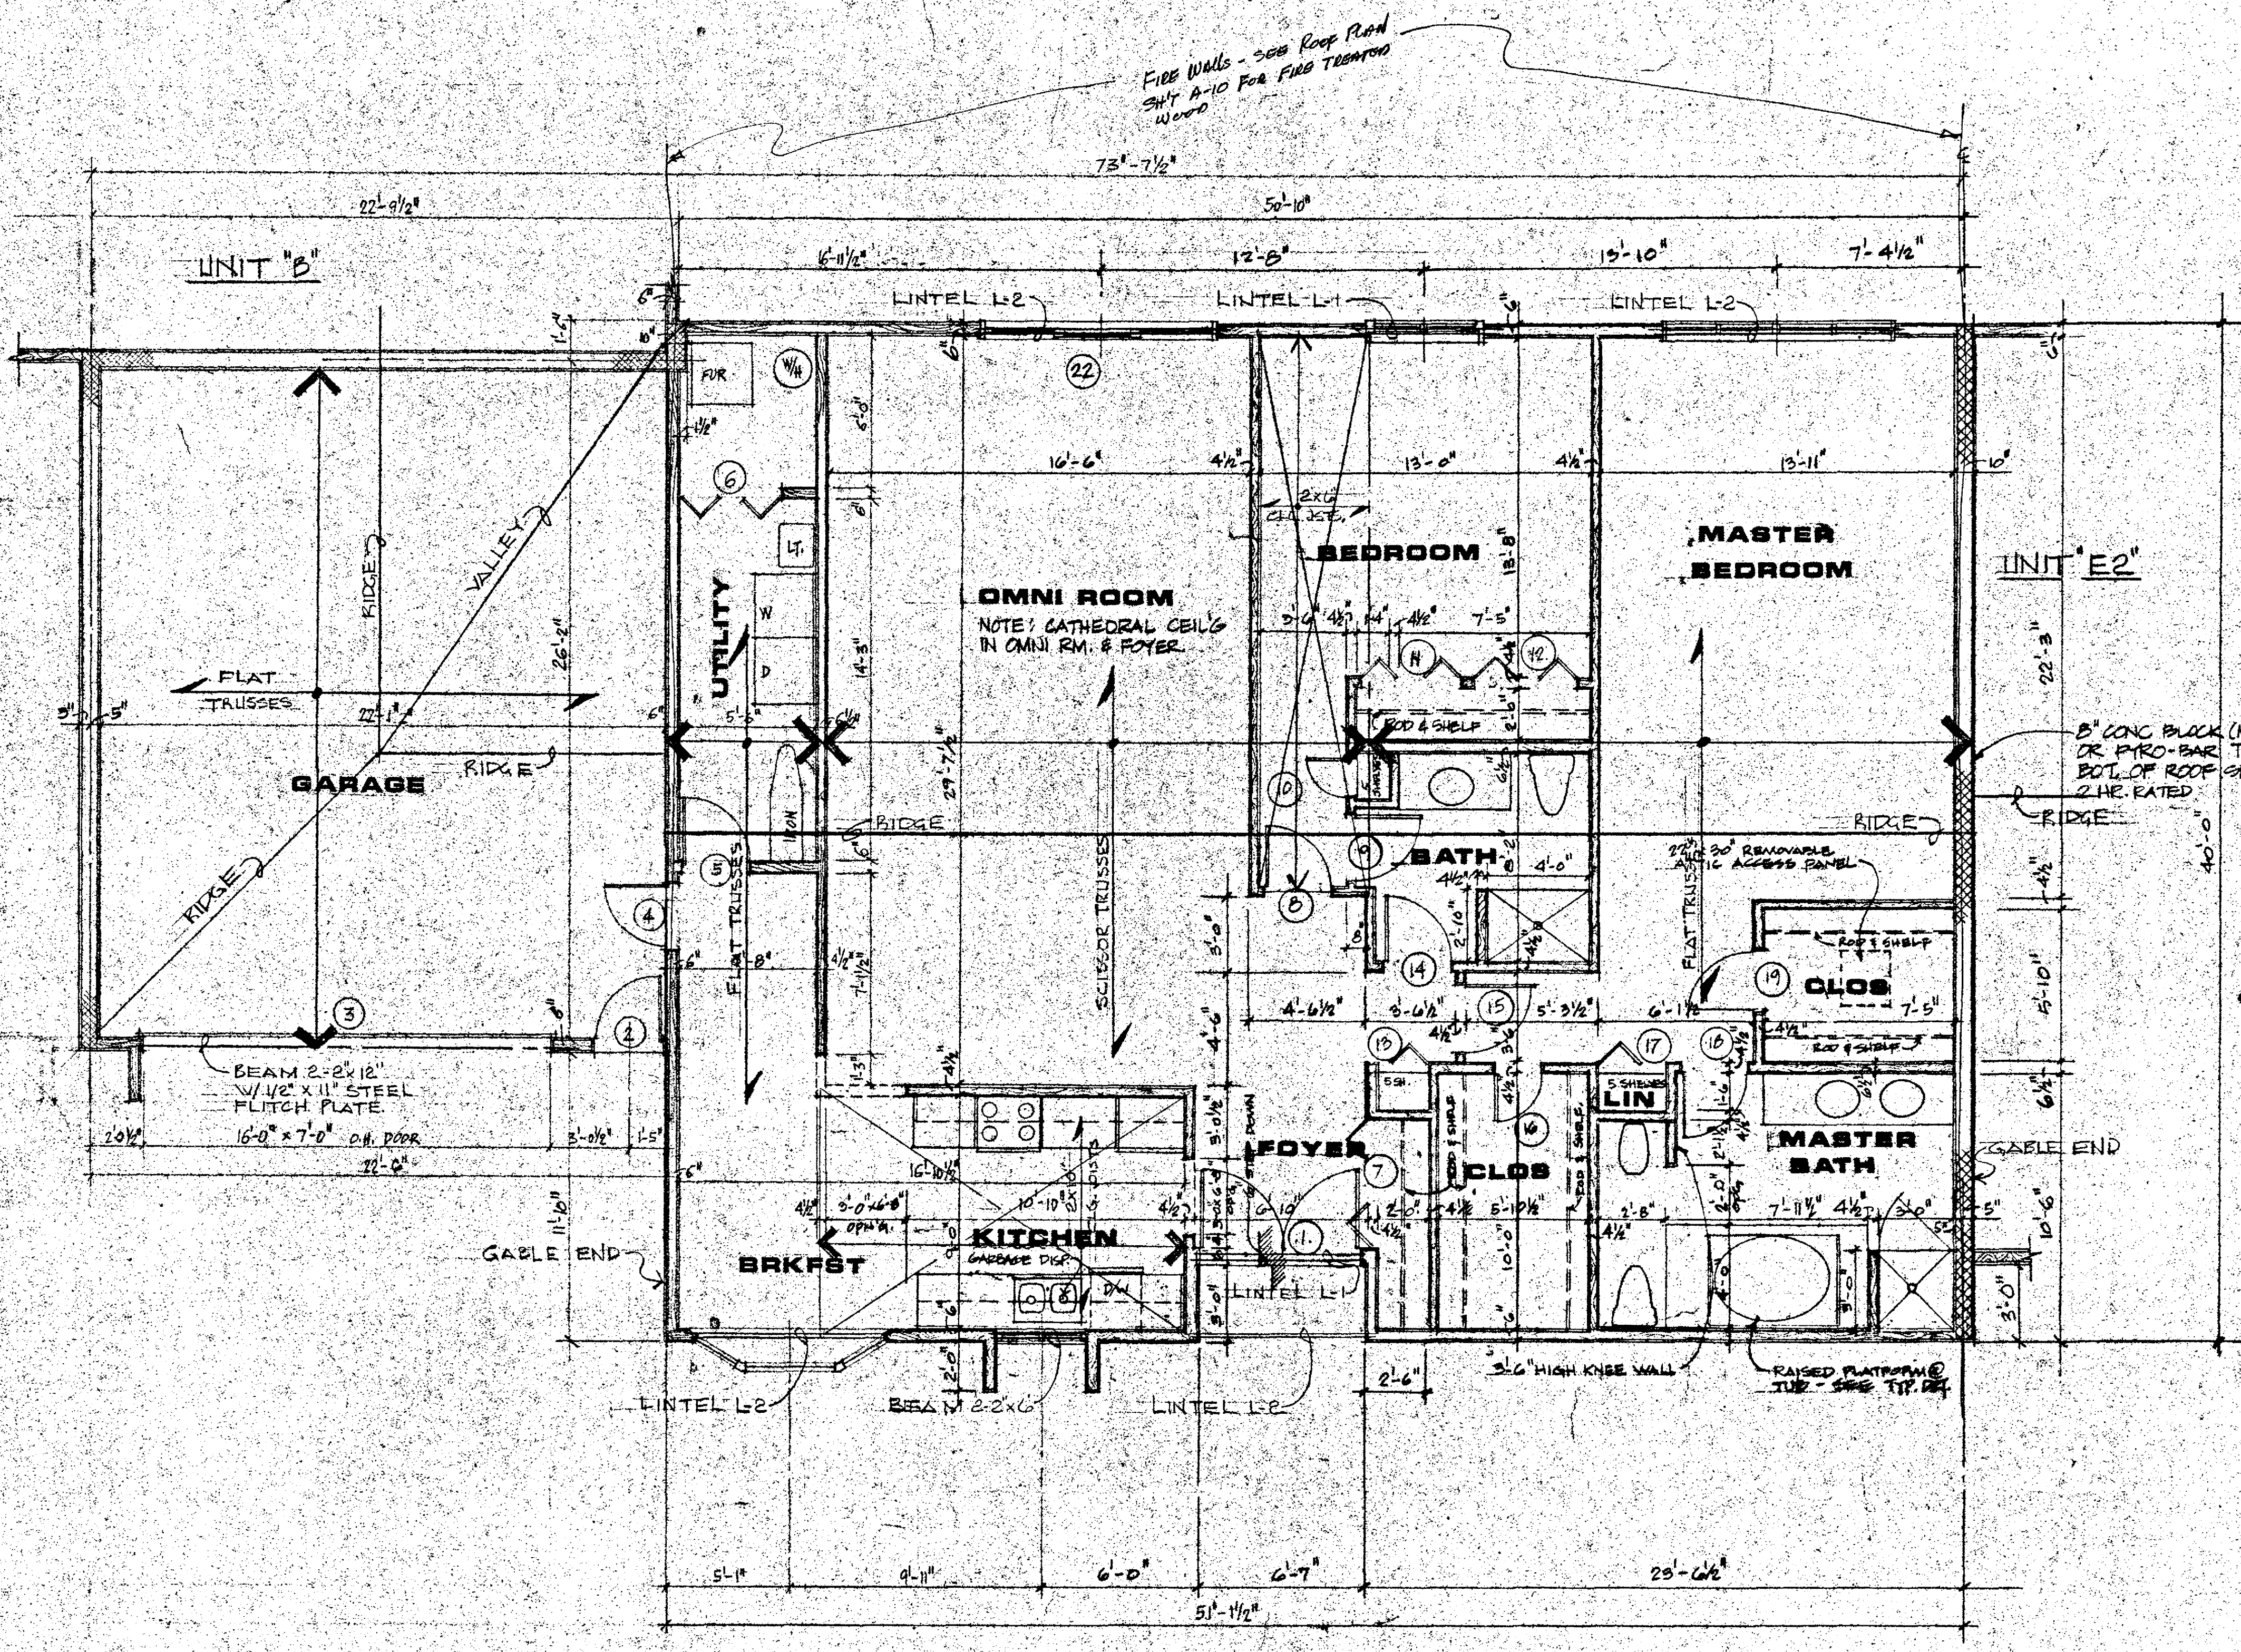


5" CONC BLOCK (MIN)
OR PYRO-BAR TO
BOT. OF ROOF SHEATHING
2" HE RATED

* IN GARAGE
2 LAYERS OF 1/2" FIRE CODE
GYP. BD. BOTH SIDES OF STUDS.
EXTEND TO BOT. OF ROOF DECK.

Mechanical Contractor to provide
for combustion air for heater portion
of utility rooms.
All fans to exhaust directly to
outside with solid connection.
With raincap.

FRAMING UNIT "A2" FLOOR PLAN


SCALE: 1/4" = 1'-0"

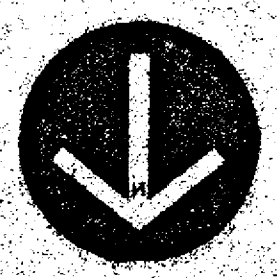

Note:
Gas meter manifolds to be located at ends of west legs of each cluster. Provide gas service in black iron pipe from meter overhead through units in plastic conduit.

FOR LINTEL SCHEDULE
SEE SHEET A-15

** 2 LAYERS OF 1/2" FIRE CODE
GYP. BD. EACH SIDE OF STUDS.
EXTEND TO BOT. OF ROOF DECK.

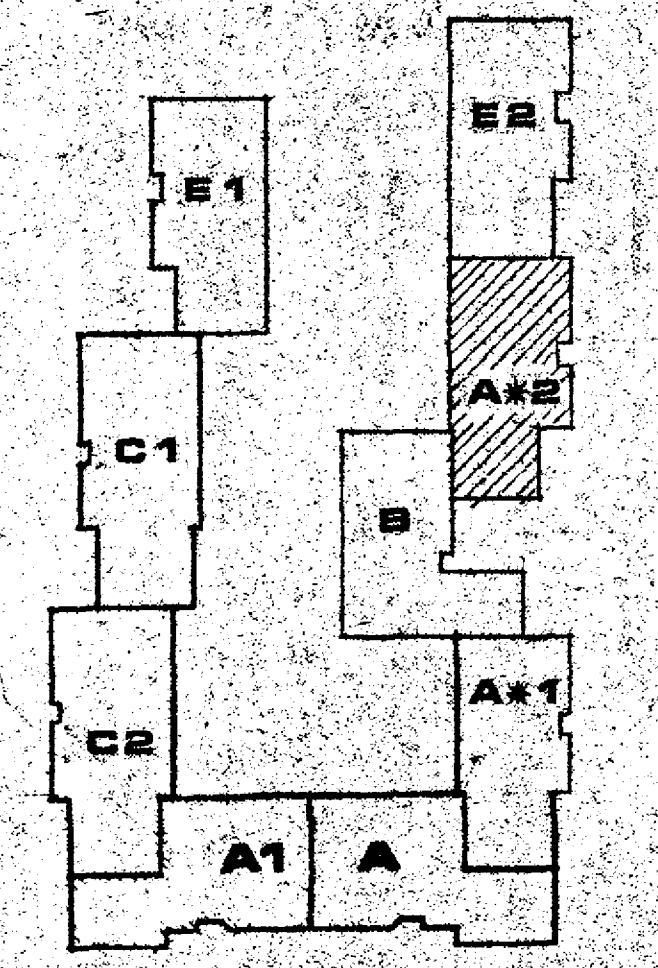

BUILDING NO. 4
KEY PLAN
SCALE: 1" = 60'-0"

WINDOW SCHEDULE

Room	Window	Description
MBR	1	4-2060 LFR
BR	1	2-2060 LR
GAR	1	3-1636 FFF
BRFST	1	AB/30-20-36-2048
KITCH	1	2-1636 LR

Rough Openings

8'-5-3/4" x 5'-6-1/2"
4'-3-1/4" x 5'-6-1/2"
5'-4-1/2" x 3'-6-1/2"
7'-5-7/8" x 4'-6-1/2"
3'-7-1/4" x 3'-6-1/2"

©COPYRIGHTED
MOSKOWITZ & COMPANY
DATE: 5/29/84
WARNING:
Certain concepts embodied
in this drawing are covered
by U.S. Patent No. 4,345,487
Maurecia J. Fishman, Inventor

FRAMING UNIT "A2"
BUILDING NO. 4

DWN. BY
DATE: 5/31/84
JOB NO. 81072

A-10