


RICHMOND ROAD CONDOMINIUMS
RICHMOND ROAD BEACHWOOD, OHIO
FOR
CONDOMINIUM CONCEPTS INC.
CLEVELAND, OHIO

KEEVA J. KEKST ASSOCIATES ARCHITECTS INC.

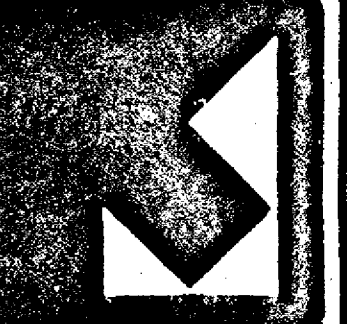


UNIT "A" 1"
BUILDING NO. 4

DWN. BY
DATE: 5/1/84
JOB NO. 81072
A-3

CONSTRUCTION DRAWINGS


Date: 5-29-84

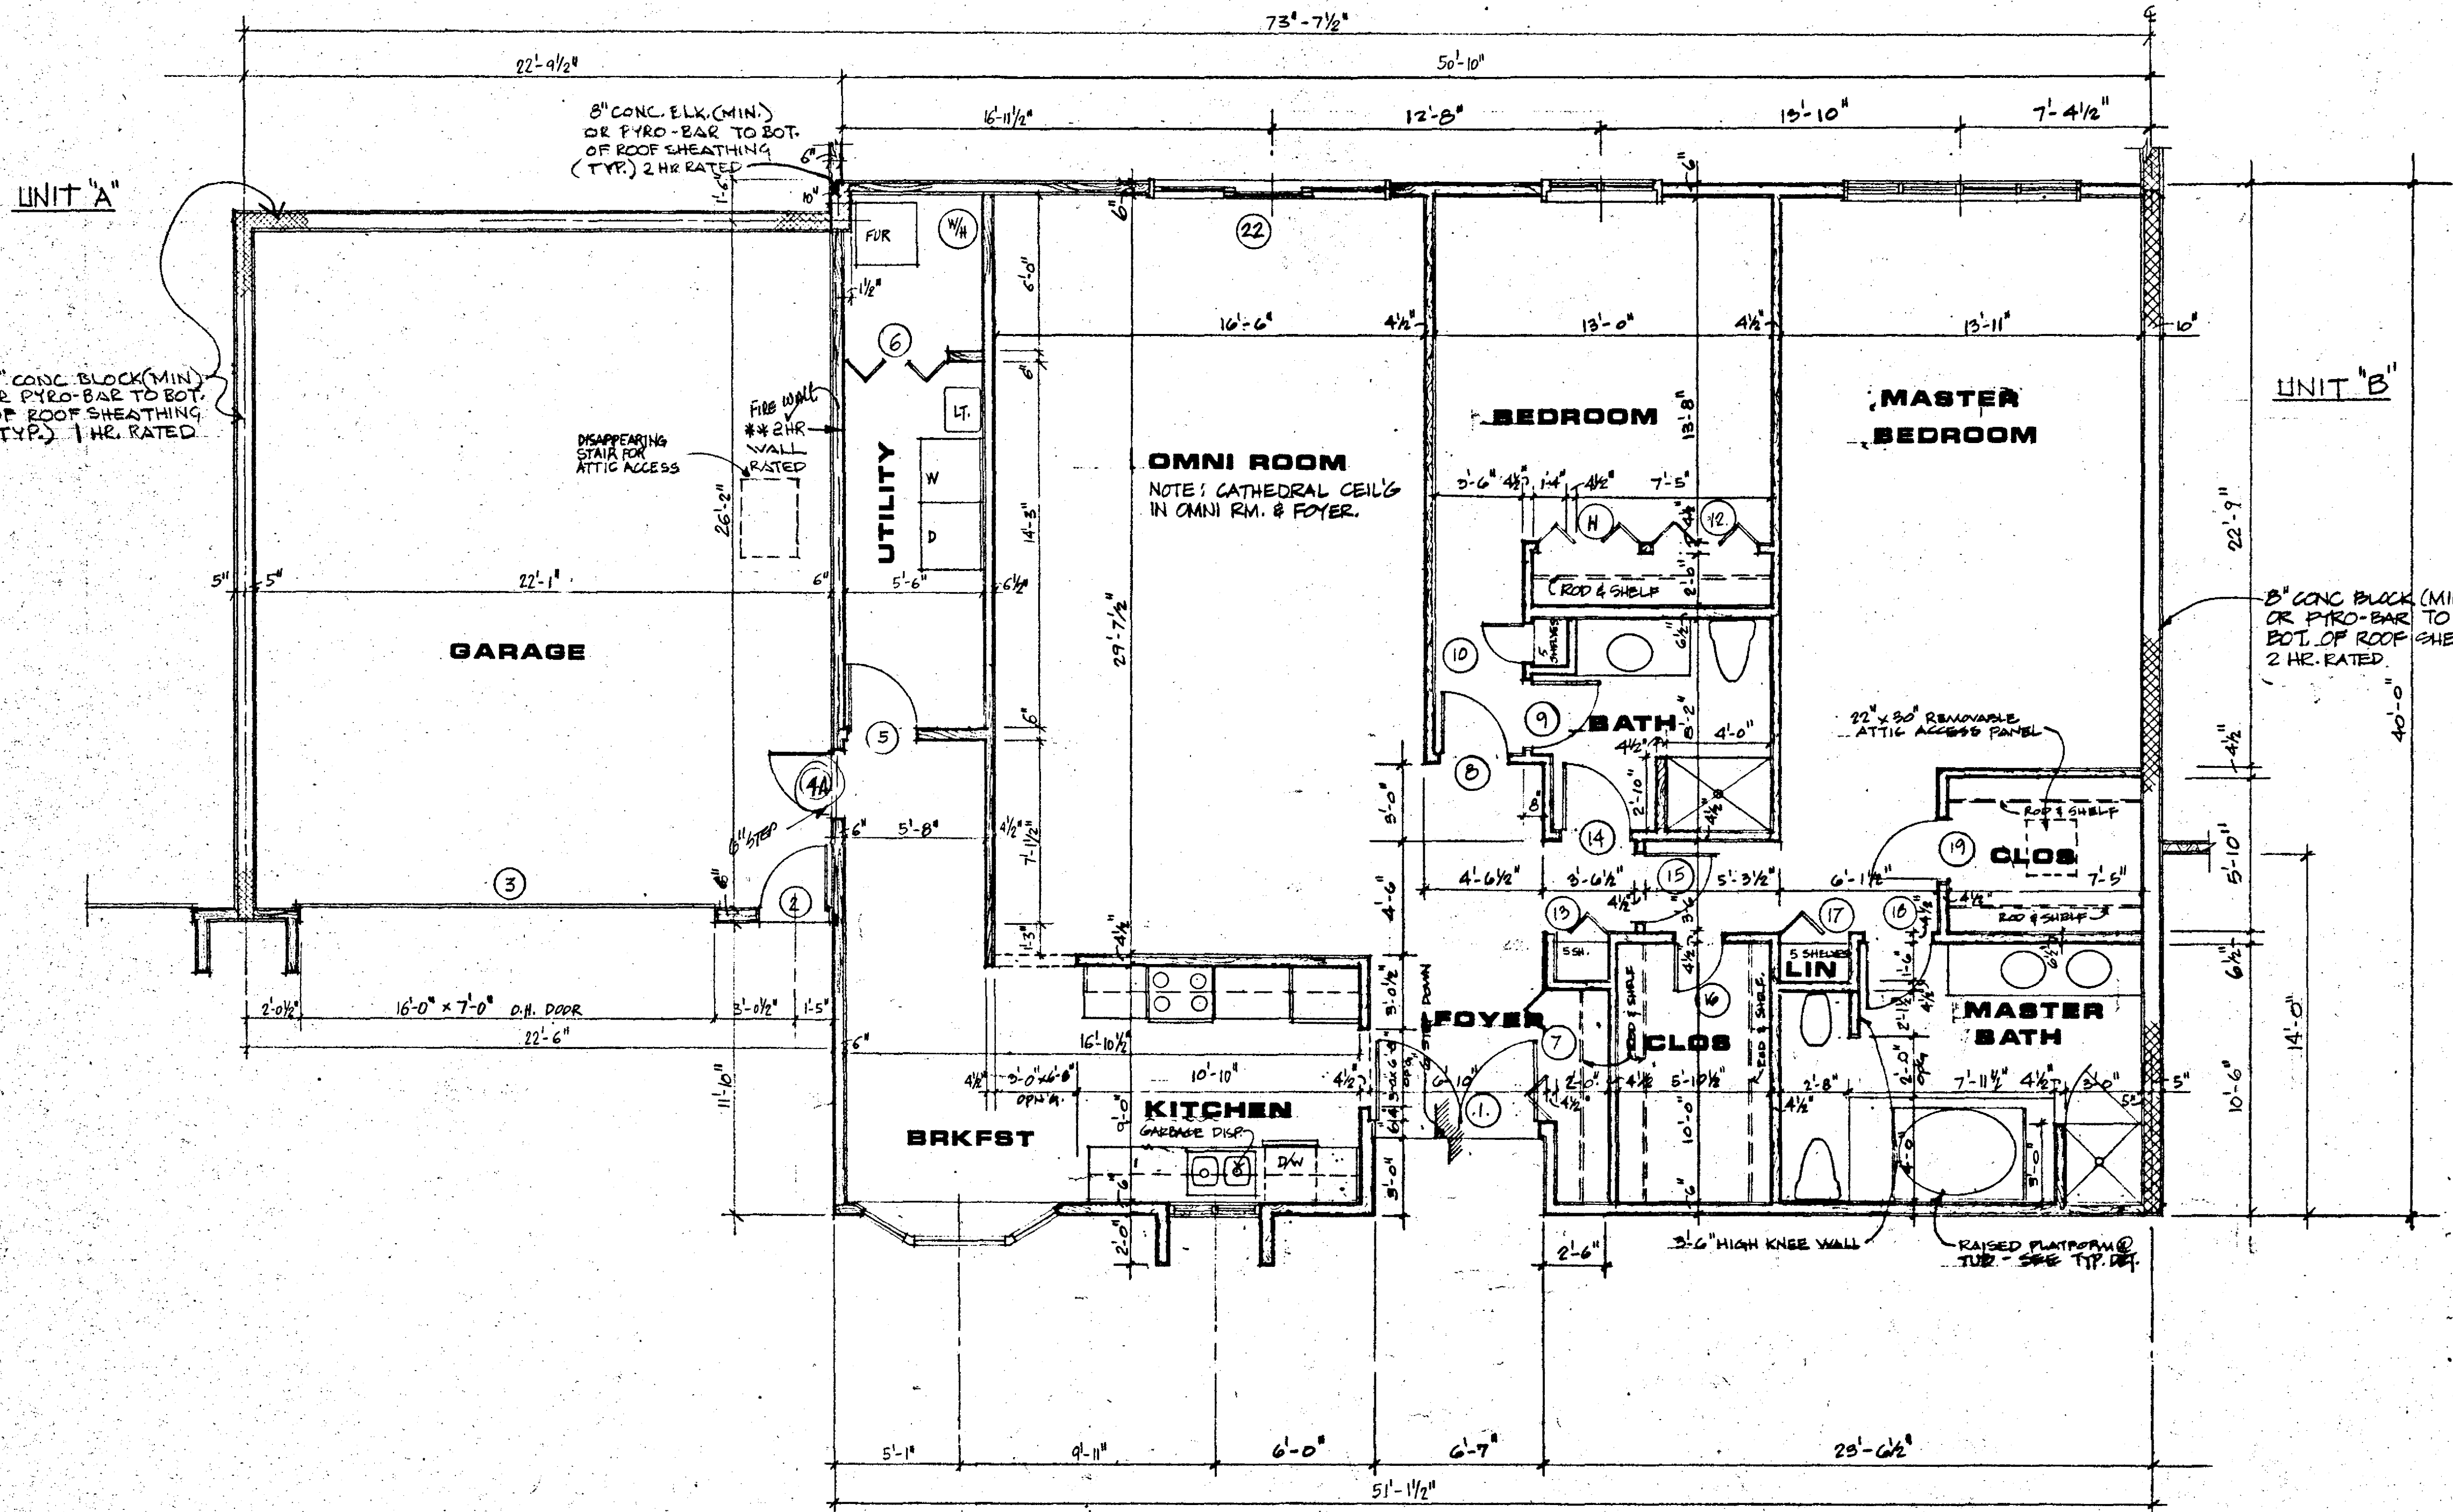

* IN GARAGE
2 LAYERS OF 1/2" FIRE CODE
GYP. BD. BOTH SIDES OF STUDS.
EXTEND TO BOT. OF ROOF DECK.

Mechanical Contractor to provide
for combustion air for heater portion
of utility rooms.
All fans to exhaust directly to
outside with solid connection.
With raincap.

- Note:
- Interior dimensions as shown on plans are correct but not to scale. Do not scale drawings.
 - See Sheet A-1 for door schedule.

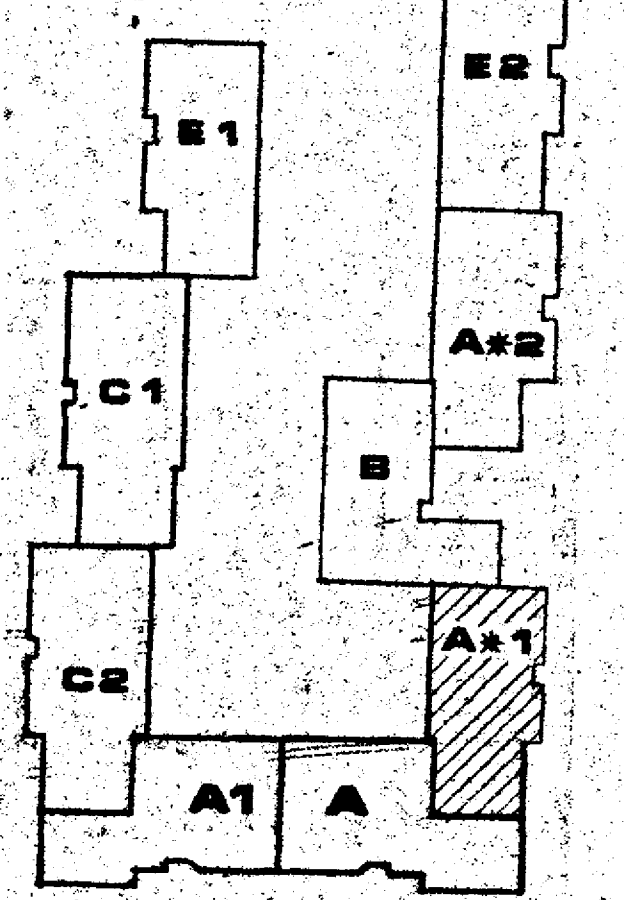

BUILDING NO. 4
KEY PLAN
SCALE 1"=60'-0"

UNIT "A*1" FLOOR PLAN

SCALE: 1/4"=1'-0"
UNIT "A*1" 2027 SQFT./GARAGE 589 SQFT.

Note:
Gas meter manifolds to be located at ends of west legs of each cluster. Provide gas service in black iron pipe from meter overhead through units in plastic conduit.

WINDOW SCHEDULE

UNIT A

Room		
MBR	1	4-2060 LFFR
BR	1	2-2060 LR
GAR	1	3-1636 FFF
BRFST	1	AB/30-20-36-2048
KITCHN	1	2-1636 LR

Rough Openings

8'-5-3/4" x 5'-6-1/2"
4'-3-1/4" x 5'-6-1/2"
5'-4-1/2" x 3'-6-1/2"
7'-3-7/8" x 4'-6-1/2"
3'-7-1/4" x 3'-6-1/2"

© COPYRIGHTED
MOSKOWITZ & COMPANY
DATE 5/29/84
WARNING:
Certain concepts embodied
in this drawing are covered
by U.S. Patent No. 4,345,487
Maurice J. Fishman, Inventor

** 2 LAYERS OF 1/2" FIRE CODE
GYP. BD. EACH SIDE OF STUDS.
EXTEND TO BOT. OF ROOF DECK.