


ELECTRICAL LEGEND

- | | |
|--------------------------------------------------|---------------------------------------------|
| ⊕ DUPLEX OUTLET 110V | ⊕ PUSH OUTLET |
| ⊕ DUPLEX OUTLET 110V W/ GROUND FAULT INTERRUPTER | ⊕ CEILING MOUNTED FIXTURE (FURNISH W/ DIMM) |
| ⊕ 220V RANGE OUTLET OR DRYER OUTLET | ⊕ WALL MOUNTED FIXTURE |
| ⊕ JUNCTION BOX | ⊕ EXHAUST FAN |
| ⊕ ONE-WAY SWITCH | ⊕ EXHAUST FAN W/ HEAT LAMP |
| ⊕ 2-WAY SWITCH | ⊕ EXHAUST FAN W/ HEAT FIXTURE |
| | P.C. - PORCELAIN PULL CHAIN |

NOTE:
Electric meter banks to be located at ends of West legs of each cluster (See Site Utility Plan). Provide fusible service disconnect above meter. Rigid metallic conduit must be provided for penetration of fire wall. Run service cable in floor slab for all units.
All fans to exhaust directly to outside with solid connections.
Alternate:
Provide plastic conduit as required for installation of Cable T.V. and/or Master T.V. Antenna. Verify location and number of outlets.

Note:
Provide for 2 porcelain pull chains in attic space of each unit - verify location.

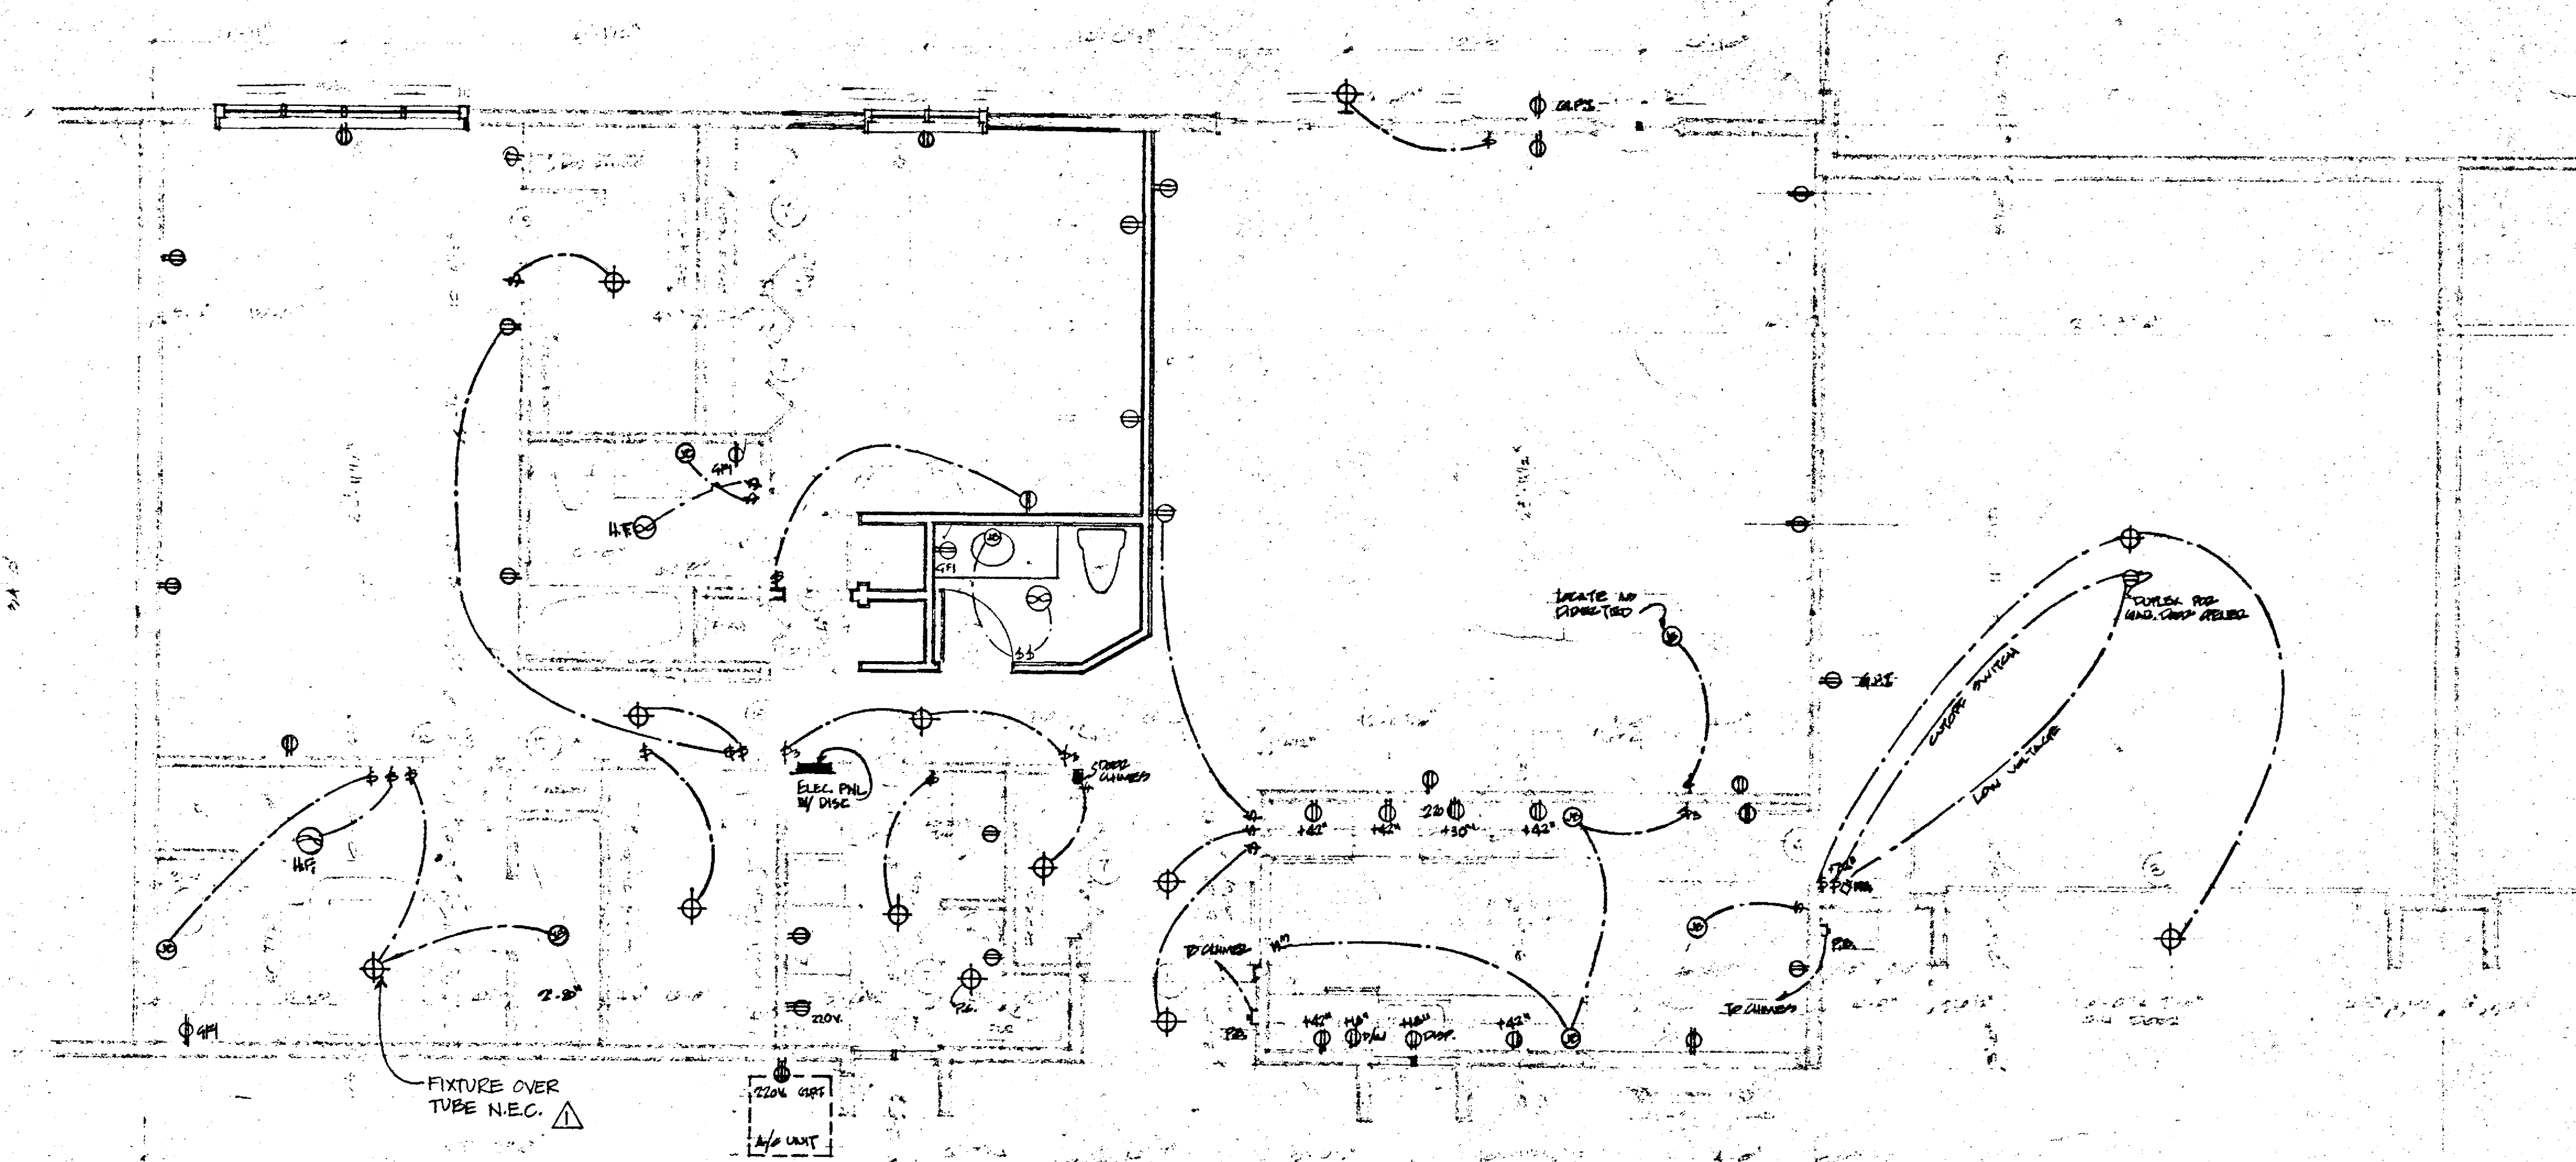

NOTE:
SEE ARCHITECTURAL FLOOR PLANS FOR EXACT WALL TYPE @ ENDS OF UNITS.

UNIT "C1" ELECTRICAL PLAN

SCALE 1/4" = 1'-0"
NOTE: UNIT "C2" SIMILAR


NOTE:
SEE ARCHITECTURAL FLOOR PLANS FOR EXACT WALL TYPE @ ENDS OF UNITS.

CONSTRUCTION DRAWINGS

Date 5-29-84

© COPYRIGHTED
MOSKOWITZ & COMPANY
DATE 5/29/84

WARNING:
Certain concepts embodied in this drawing are covered by U.S. Patent No. 4,345,407
Maurice J. Fishman, Inventor

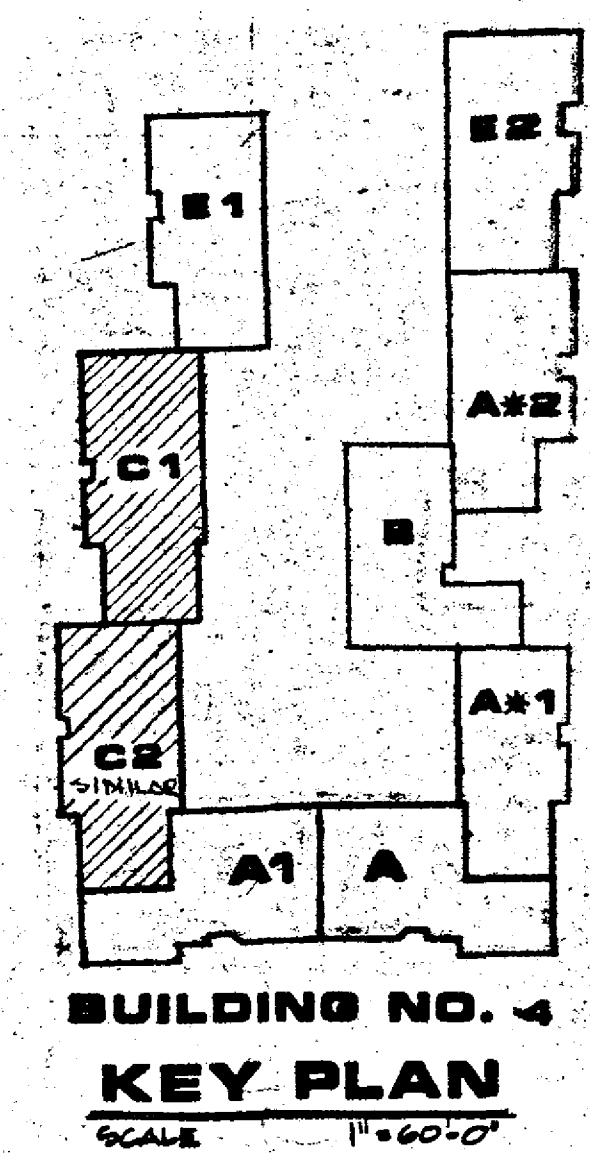

BUILDING NO. 4
KEY PLAN
SCALE 1" = 60'-0"

RICHMOND ROAD CONDOMINIUMS
 RICHMOND ROAD BEACHWOOD, OHIO
 FOR
 CONDOMINIUM CONCEPTS INC.
 CLEVELAND OHIO

ELECTRICAL
UNIT "C1"
 AND "C2" SIMILAR
BUILDING NO. 4

DATE 5/29/84
BY BJO

SCALE 1" = 4'